


CHARLOTTE COUNTY PUBLIC SAFETY BUILDING SHERIFF DEPT. LIFT STATION AND FORCE MAIN DESIGN

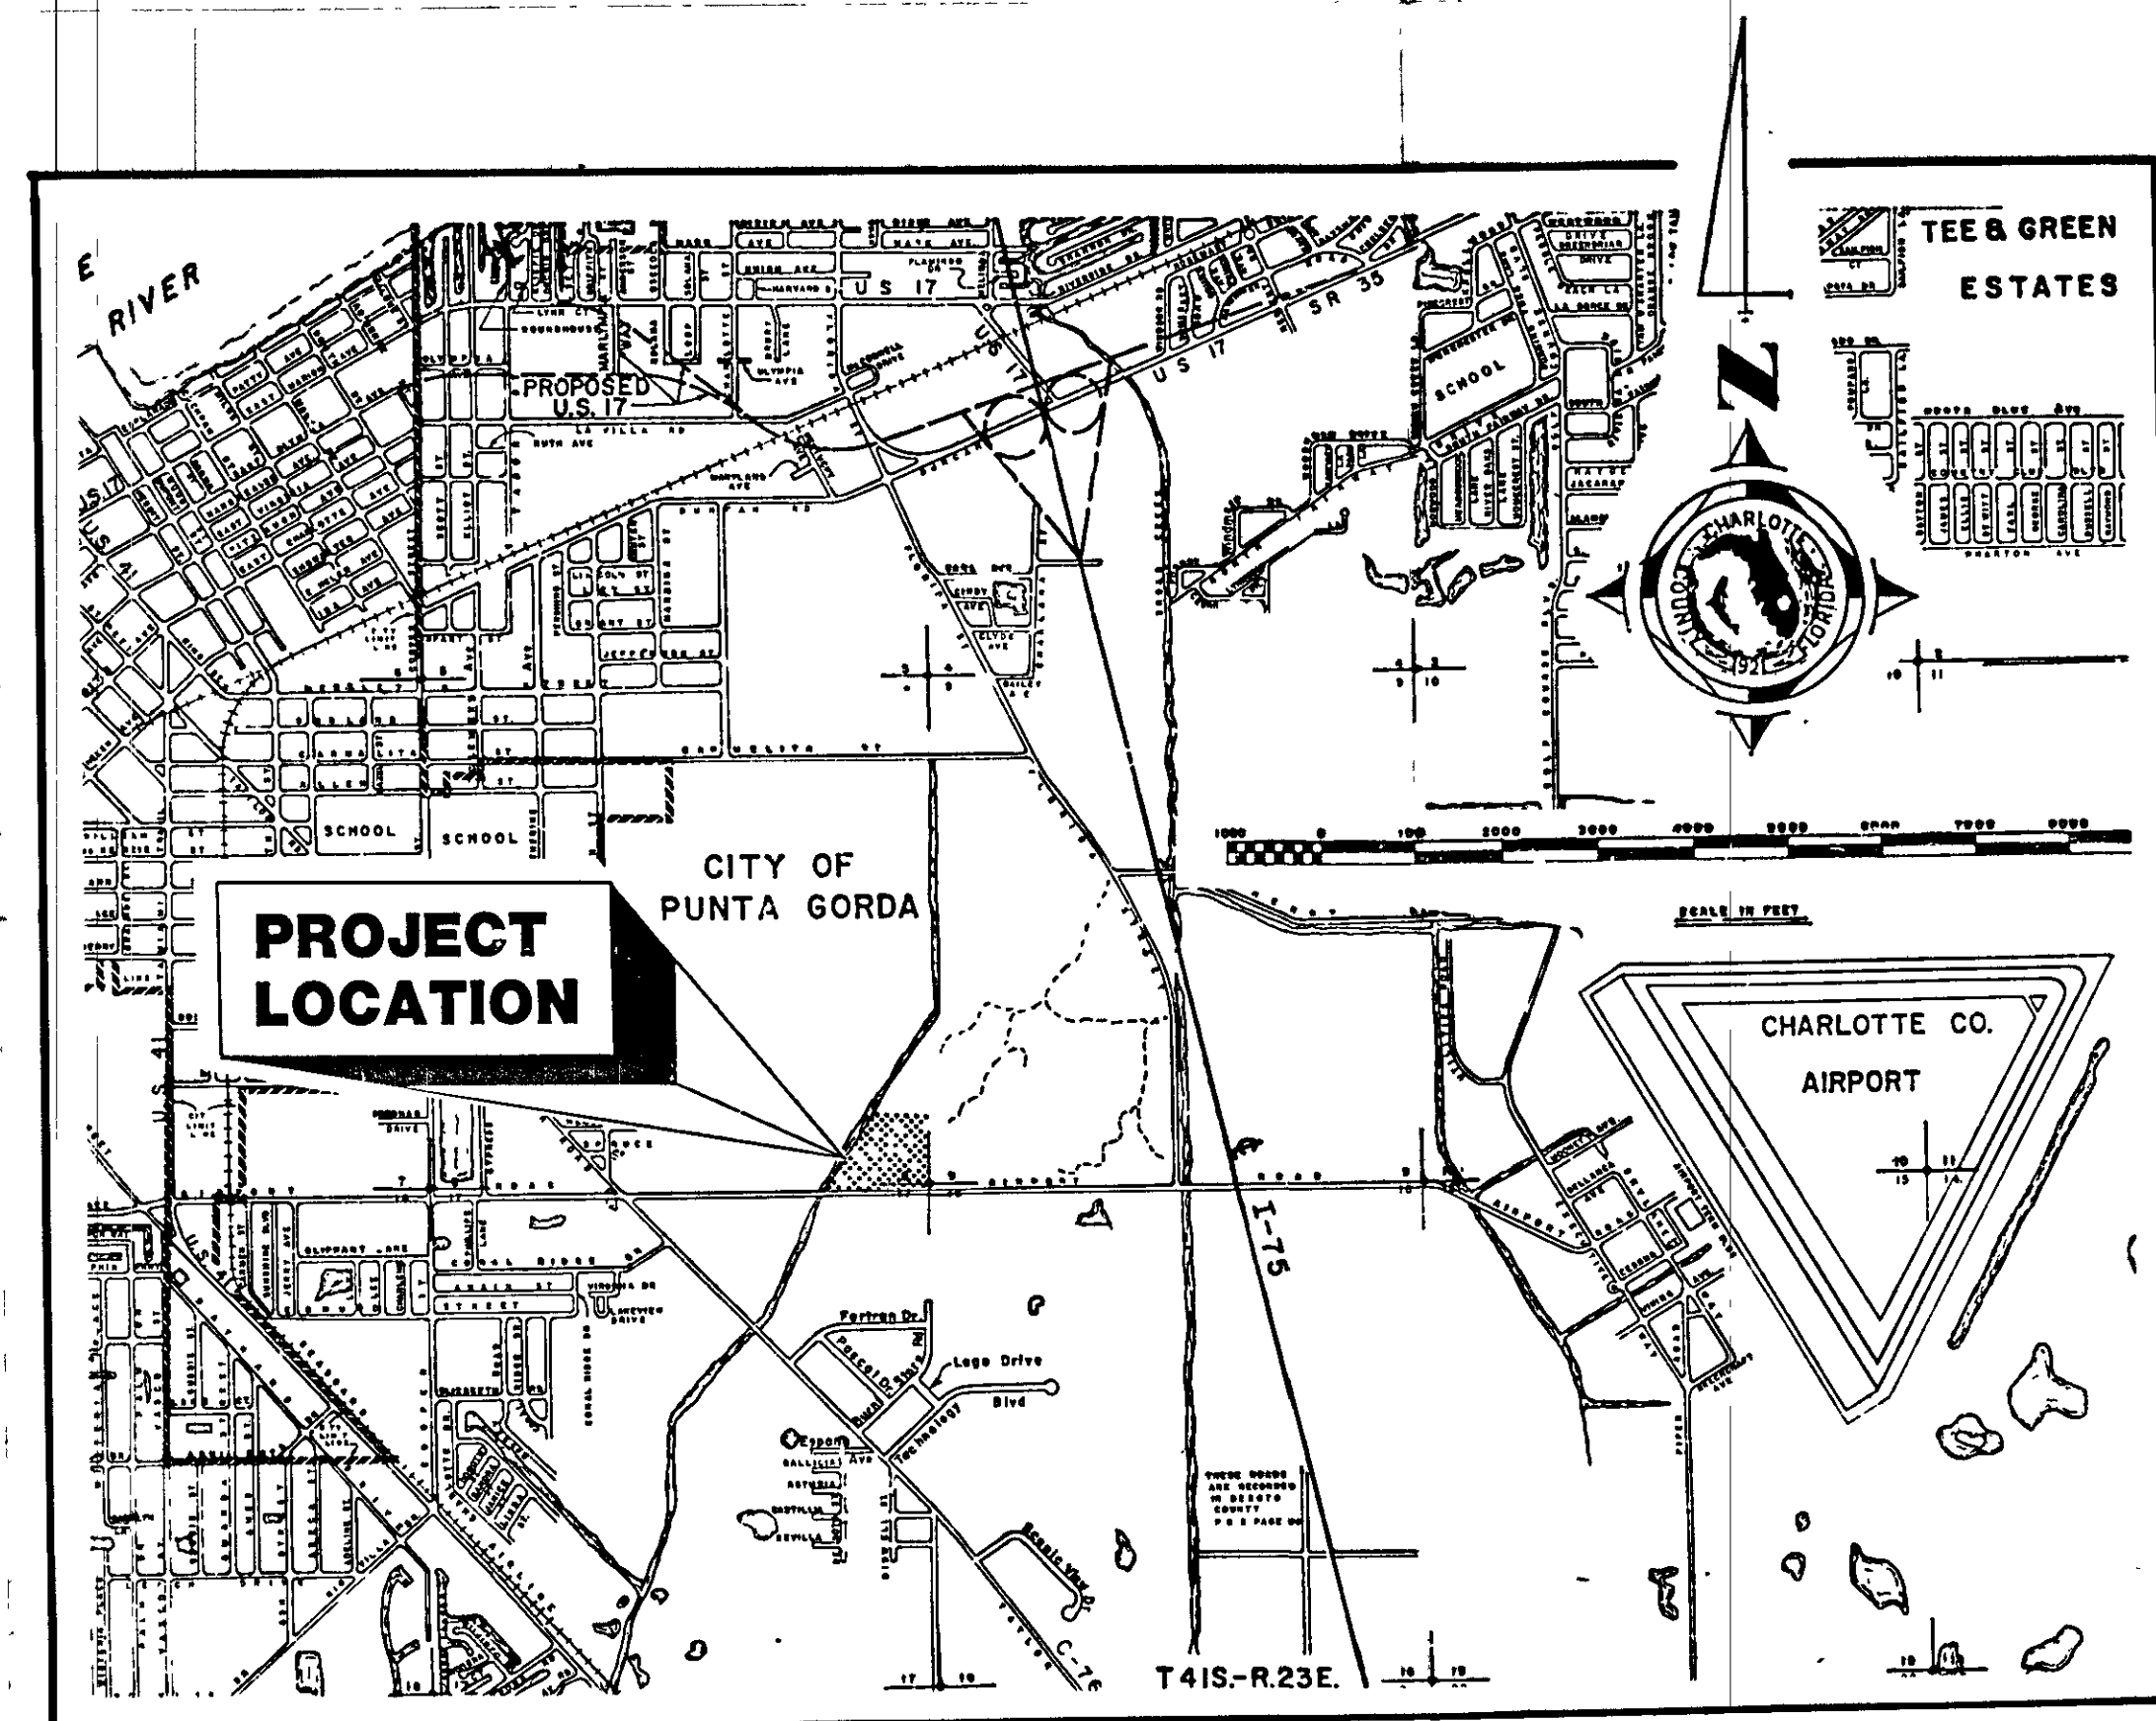


T. 41 - R. 23 E. - SEC. 8

INDEX OF UTILITY PLANS	
SHEET NO.	SHEET DESCRIPTION
1	COVER SHEET
2	PLAN
3	PLAN & PROFILE
4	DETAILS

APPROVED BY: _____
JIM BYRD COUNTY ENGINEER
FLORIDA P.E. NO. 0037242

DATE: _____

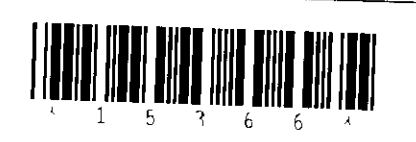

	COUNTY OF CHARLOTTE COUNTY ENGINEERING DEPARTMENT PUNTA GORDA, FLORIDA	
	TIE-IN WITH CITY OF PUNTA GORDA UTILITIES	
SCALE NONE		
DES BY S.S.		
DRW BY A.J.D.		
CHK BY S.S.		
SURVEYED BY		SHEET 1 OF 4
APPROVED BY		DRAWING No 803
DATE: 12/12/88	JOB No	